


# PUMP STATION SITE DETAIL

NOT TO SCALE

## NOTES:

\* RPZ MUST MEET THE UNIVERSITY OF SOUTHERN CALIFORNIA STANDARDS  
LIFT STATION SITE PLAN MAY CHANGE DUE TO THE LAND & SPACE AVAILABLE

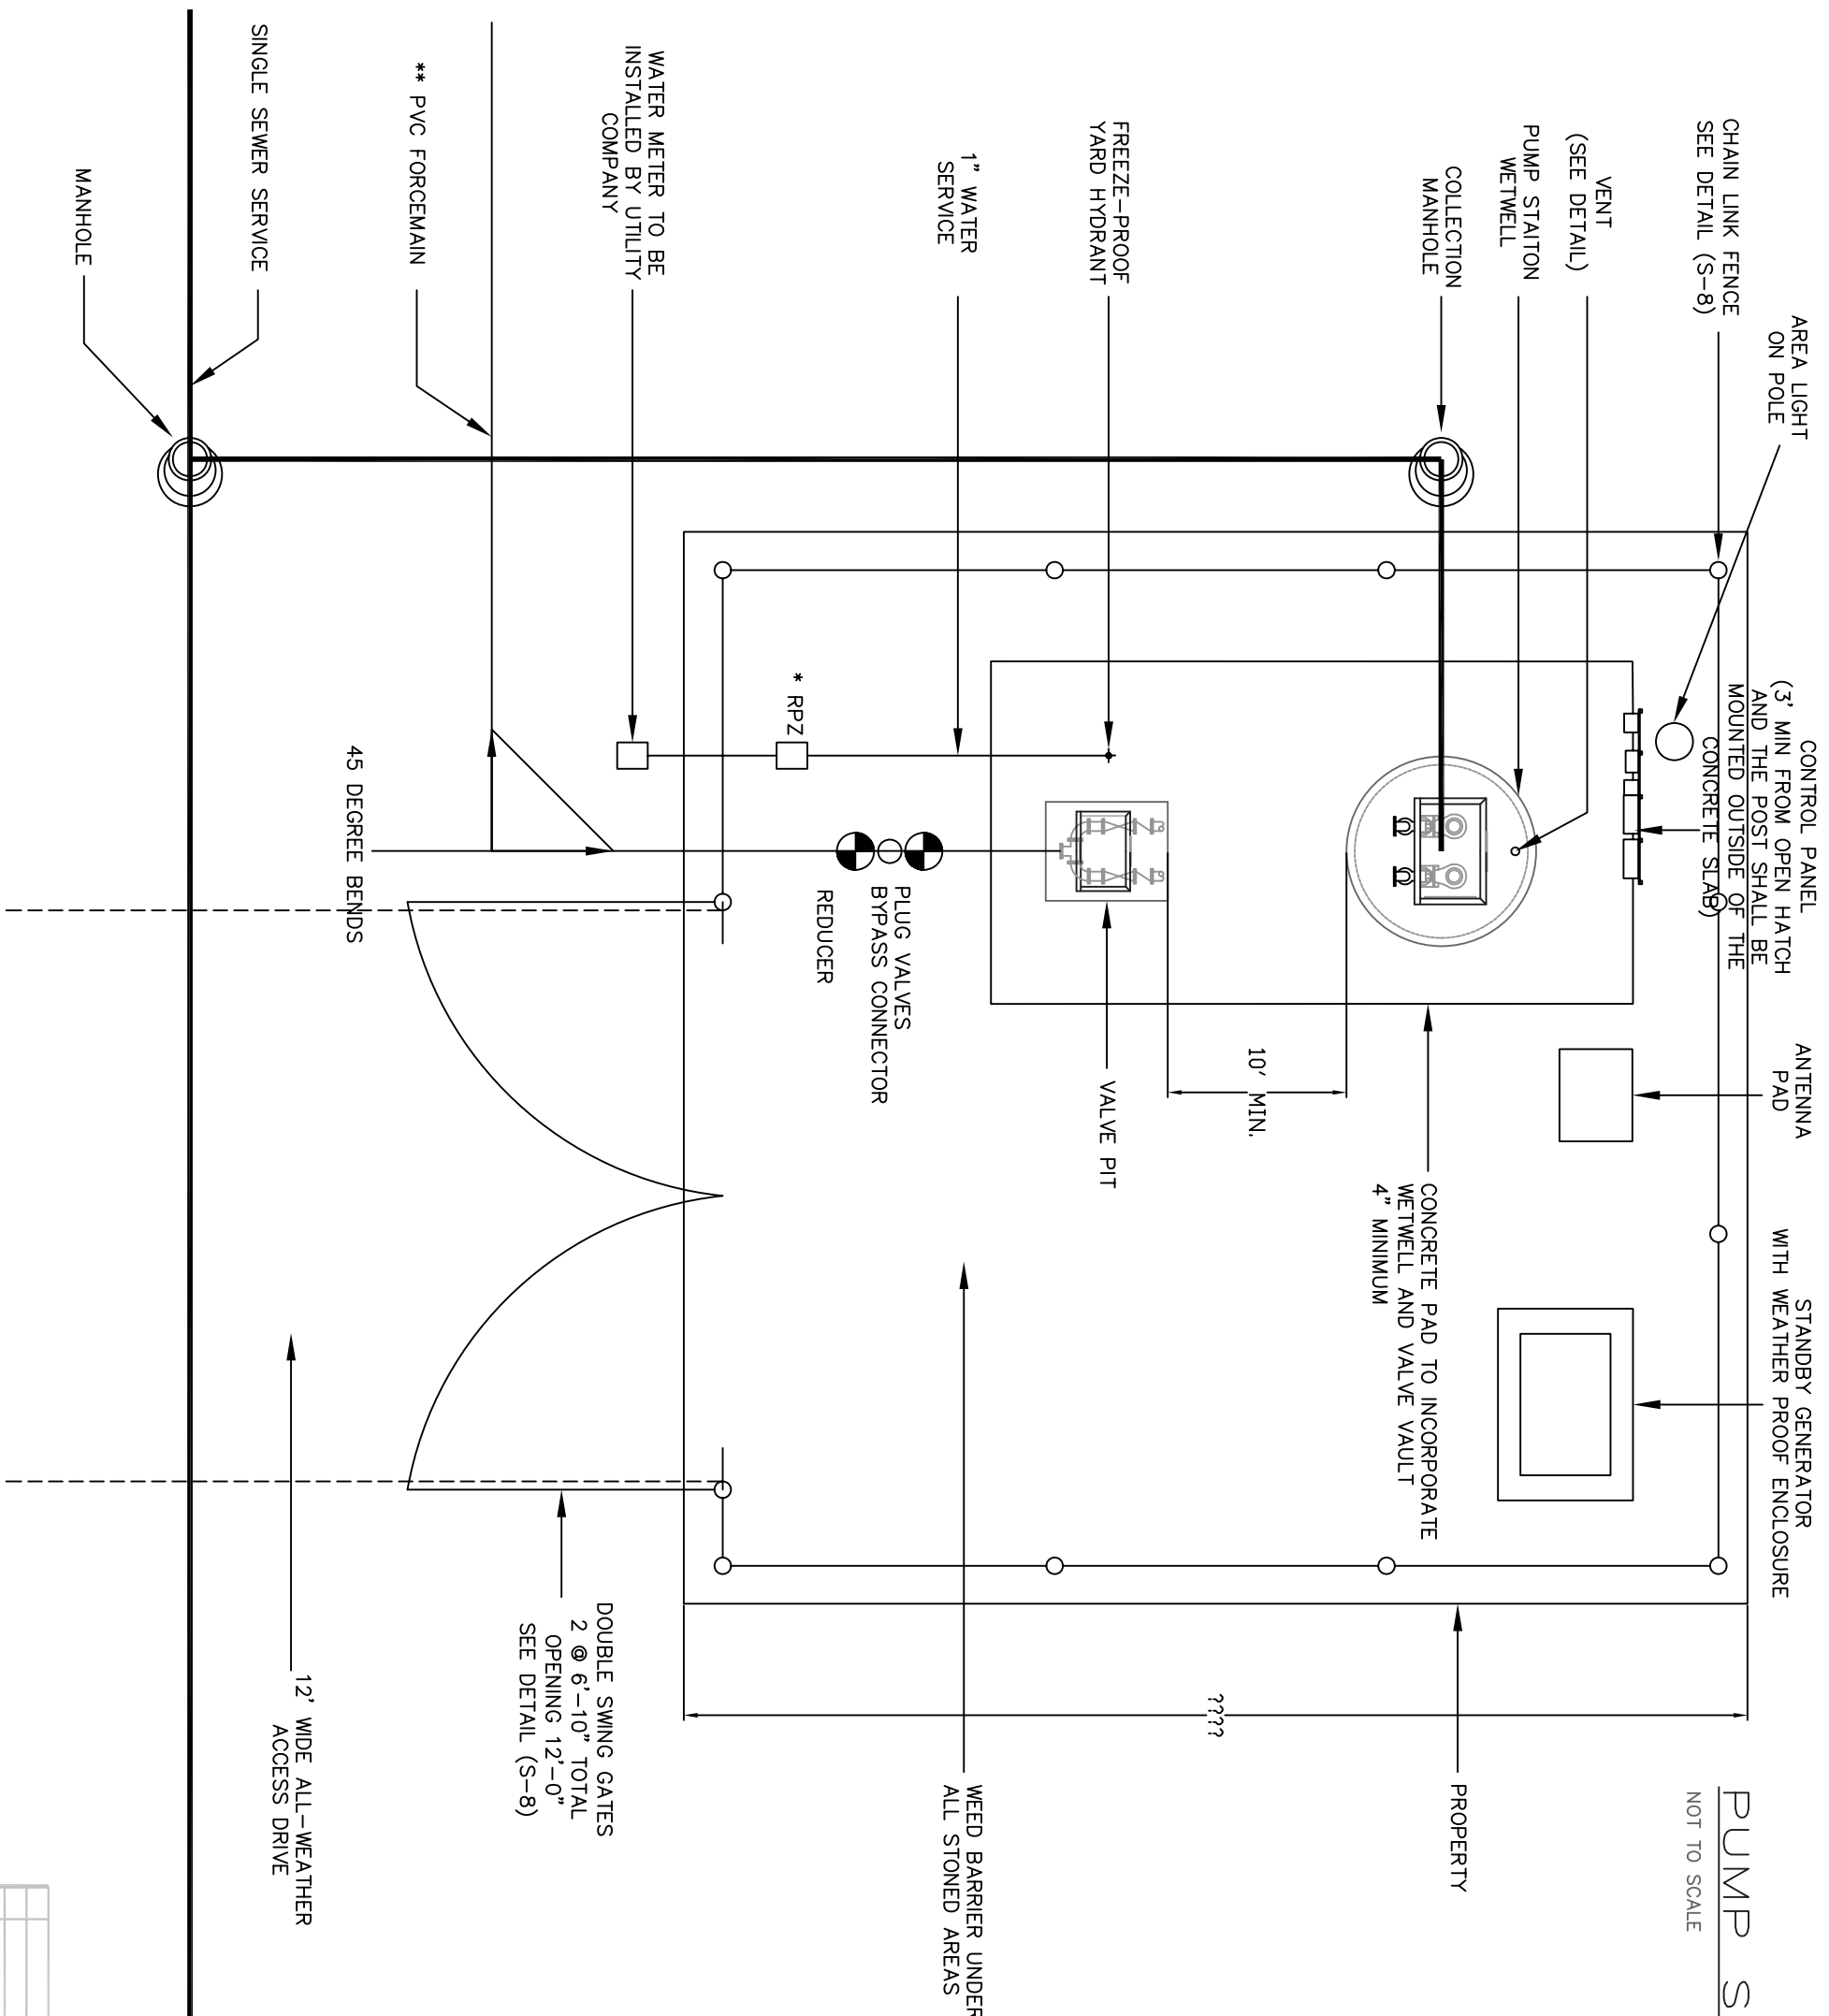

<b>Brunswick County</b>		DATE	04/04/05	DRAWN BY	S.T.E	ENGINEER	R. FALDR	SCALE	NONE
PROJECT		SEWAGE LIFT STATION PUMP STATION SITE DETAIL							
BRUNSWICK CO.		DRAWING NUMBER							
SCADA SYSTEM		S-5							
NO.	REVISION	DATE	APPROVED BY						
3	AS BUILT	8/11/99	M. MAY						
2	FIR CONSTRUCTION	12/16/98	M. MAY						
1	FIR SUBMITTAL	7/08/98	M. MAY						